


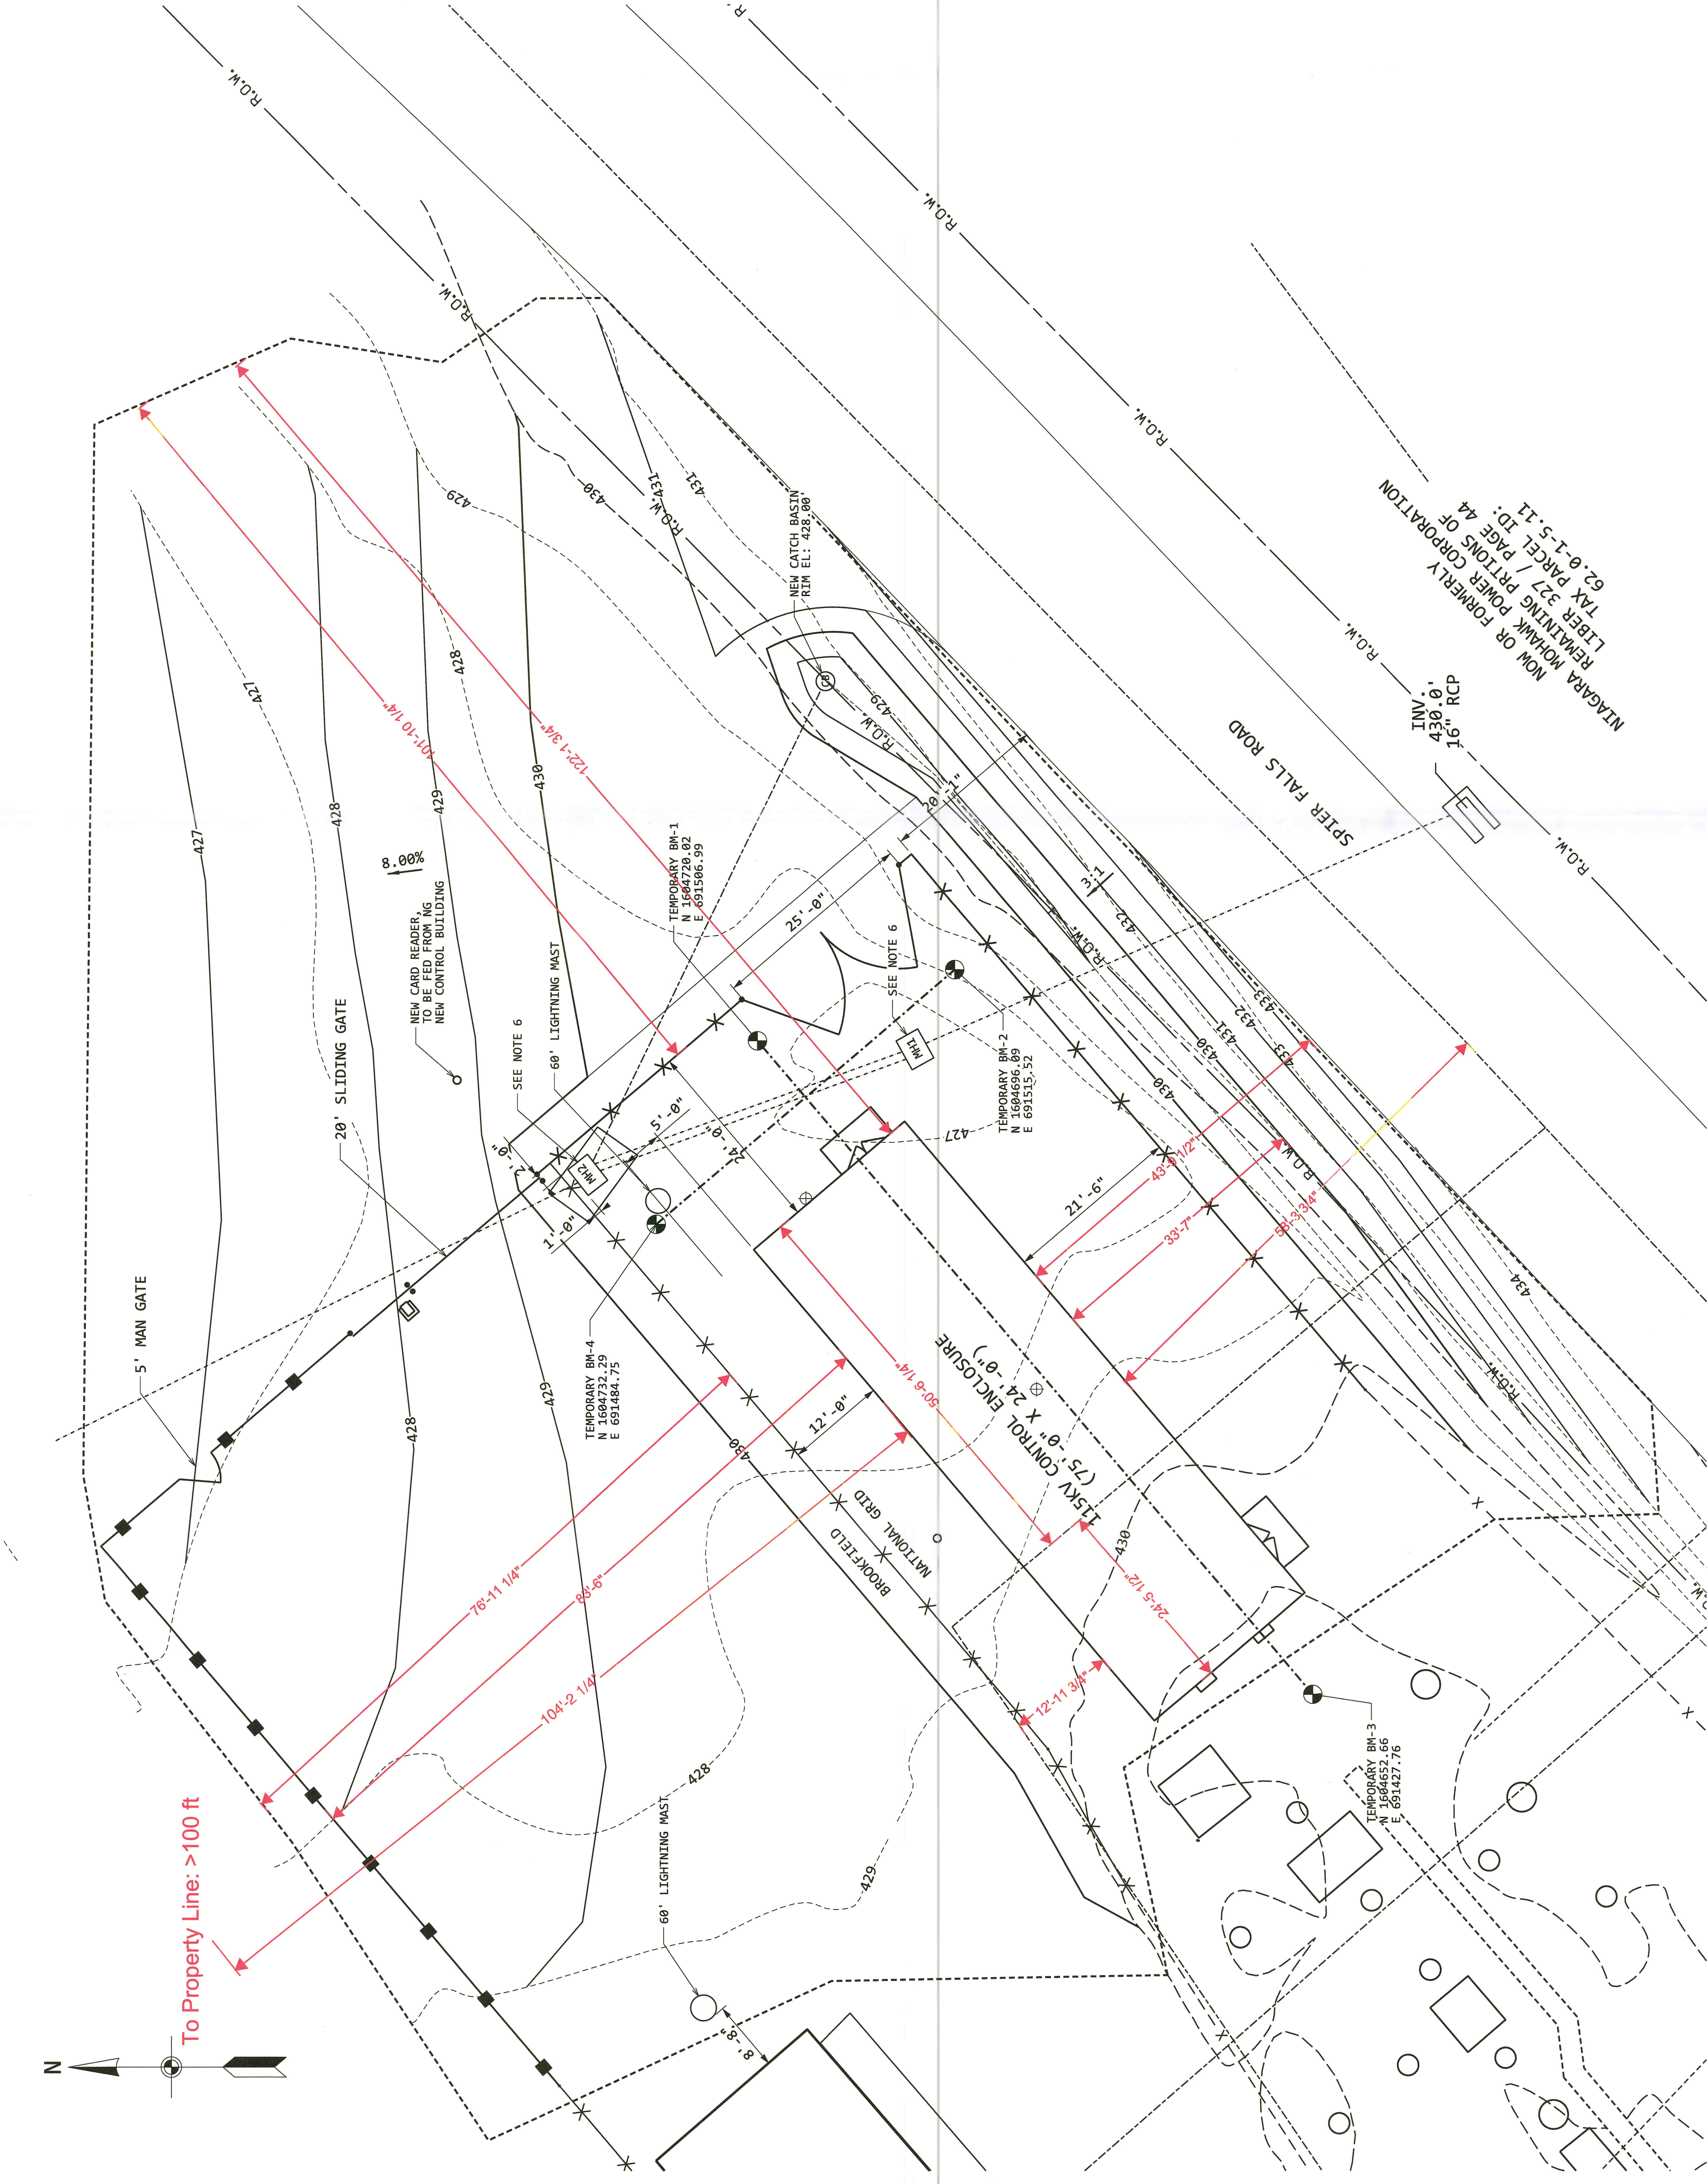

- NOTES:
- GENERAL NOTES ON THIS DRAWING ARE APPLICABLE TO ALL SITE DEVELOPMENT DRAWINGS.
 - TOPOGRAPHIC SURVEY DATED 10/17/2024 WAS PERFORMED BY NATIONAL GRID.
 - HORIZONTAL DATUM: NAD83, NEW YORK STATE PLANE COORDINATE SYSTEM, EAST ZONE. VERTICAL DATUM: NAVD88.
 - CONTRACTOR SHALL VERIFY ALL EXISTING UTILITIES PRIOR TO CONSTRUCTION BY CONTACTING DIG SAFELY NEW YORK (811).
 - PHYSICAL ELECTRICAL LAYOUT DEPICTED ON THIS DRAWING IS FOR REFERENCE PURPOSES ONLY. REFER TO ELECTRICAL ABOVE GRADE IFC DRAWINGS FOR DIMENSIONS AND CONSTRUCTION INFORMATION.
 - EXISTING CATCH BASINS TO BE CONVERTED TO A SOLID WALLED MANHOLE WITH A COVER THAT MEETS THE DESIGN CRITERIA OF AASHTO FOR HS-20 LOADING TO BE INSTALLED.
 - ALL WORK ON THE BROOKFIELD SIDE OF THE GATE WILL BE CONSTRUCTED AND INSTALLED BY OTHERS.


- LEGEND:
- 431--- -EXISTING 1' GROUND CONTOUR
 - 430--- -EXISTING 5' GROUND CONTOUR
 - 431--- -NEW 1' GROUND CONTOUR
 - 430--- -NEW 5' GROUND CONTOUR
 - X X X X X -NEW FENCE
 - ■ ■ ■ ■ -FENCE BY OTHERS
 - --- -PROPERTY LINES
 - R.O.W. --- -RIGHT-OF-WAY
 - - -X - - - -EXISTING FENCE
 - ⊕ -EXISTING SOIL BORING
 - --- -LIMITS OF DISTURBANCE
 - --- -NEW UNDERGROUND PIPE
 - --- -EXISTING UNDERGROUND PIPE
 - MH -MANHOLE
 - CB -NEW CATCH BASIN
 - ⊙ -TEMPORARY BENCHMARK

- SHEET INDEX
- EXISTING CONDITIONS PLAN
 - DEMOLITION PLAN
 - GRADING AND DRAINAGE PLAN
 - GRADING AND DRAINAGE DETAILS
 - GRADING AND DRAINAGE SECTIONS
 - GRADING AND DRAINAGE SECTIONS
 - SURFACING AND FENCING DETAILS
 - EROSION AND SEDIMENT CONTROL PLAN
 - EROSION AND SEDIMENT CONTROL DETAILS
 - VEHICLE TRACKING PLAN

APPROVED FOR CONSTRUCTION

THE DESIGN AND USE OF THE NATIVE FORMAT CAD FILE OF THIS DRAWING UNCONTROLLED THE USER SHALL VERIFY TRACEABILITY OF THIS DRAWING TO THE LATEST CONTROLLED VERSION.

WARNING
THIS DRAWING HAS BEEN APPROVED BY A NEW YORK STATE PROFESSIONAL ENGINEER IN THE CITY OF NEW YORK AND IS NOT TO BE REPRODUCED OR TRANSMITTED IN ANY FORM OR BY ANY MEANS, WITHOUT THE WRITTEN PERMISSION OF THE ENGINEER.

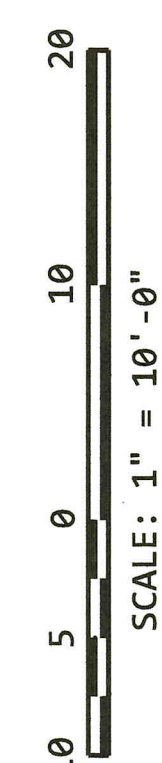


	BLACK & VEATCH		PROJECT #421275		ENGINEER	AS DRAWN	SBS
	NEW YORK, LLP		CHECKED		CS DATE	8/17/2025	
	NWPC SPIER FALLS HYDRO STATION 34		ORIENTAL		ISSUE DATE	3/25	
	115KV-34.5KV STATION		FILE		INDEX	2-0 - S13 - M27	
OVERALL SITE PLAN		DRAWING NUMBER		67800		SHEET NUMBER	
		ACCOUNT NUMBER		90600248408		FINAL	

A	B	C	D	E	F	G
FOR H CONSTRUCTION						

NOTES:

1. SEE DRAWING 67800-001 FOR GENERAL NOTES APPLICABLE TO ALL SITE DEVELOPMENT DRAWINGS.

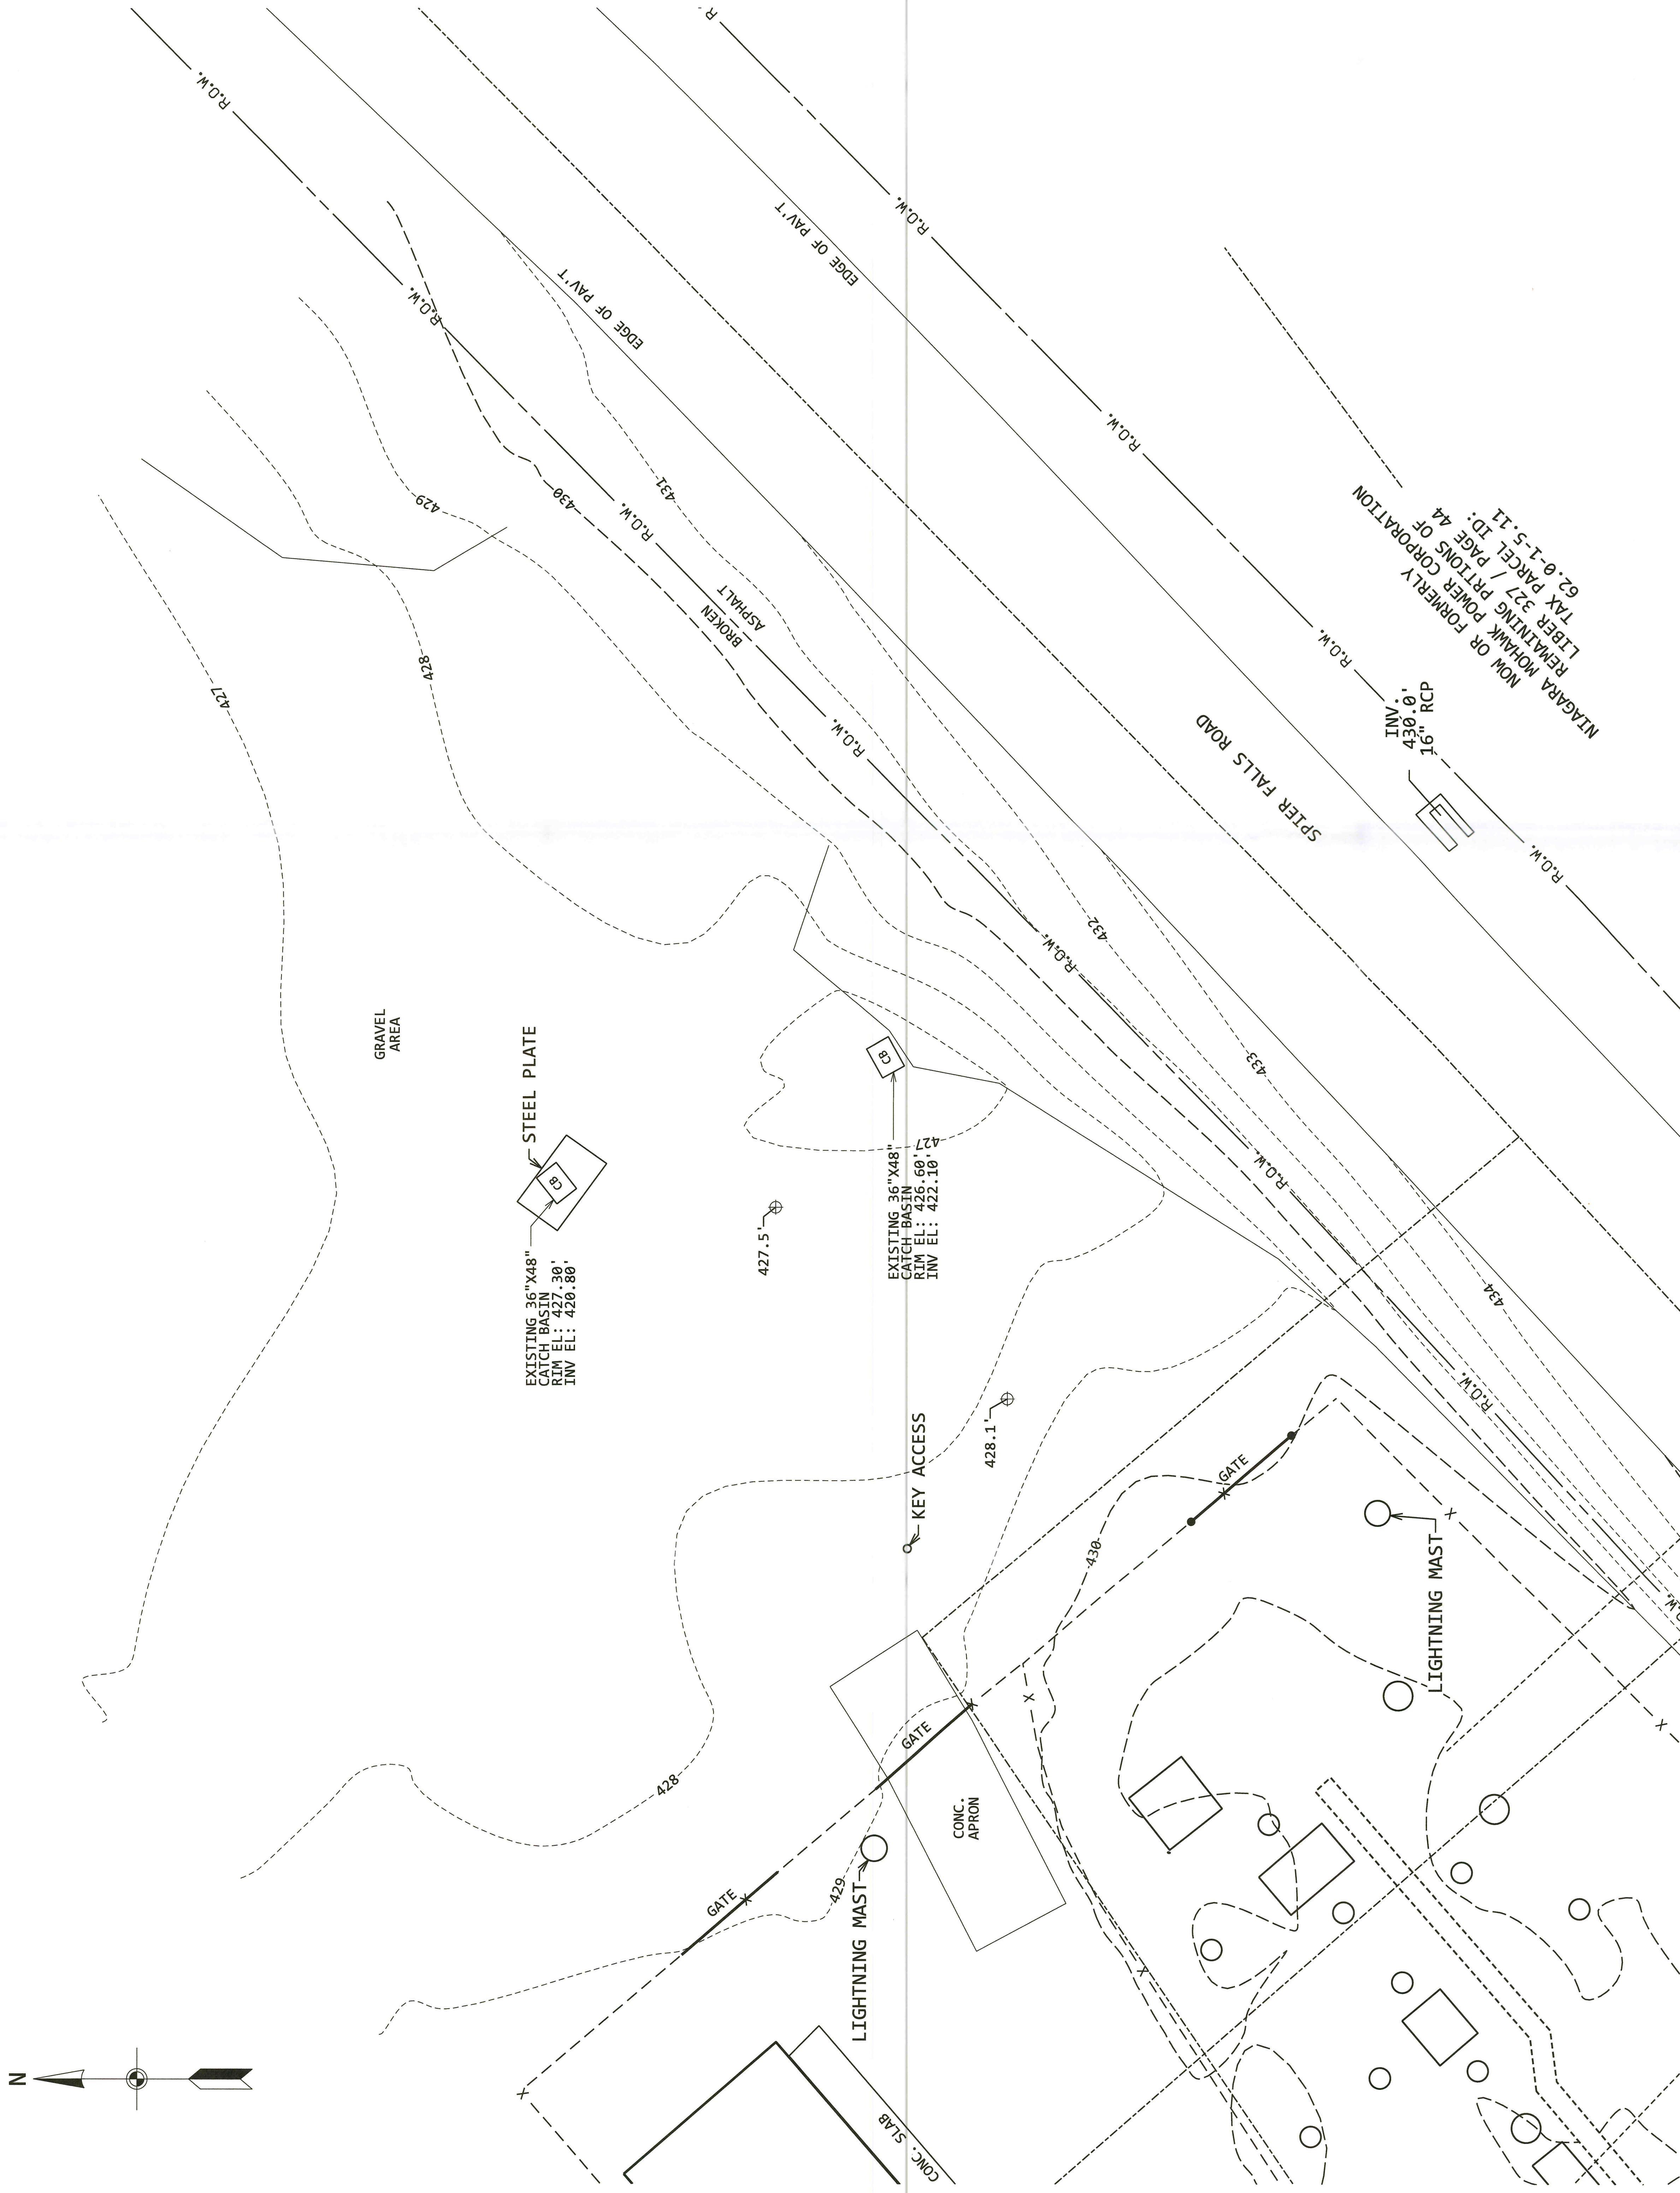

**APPROVED FOR
CONSTRUCTION**

THE DISTRIBUTION AND USE OF THE NATIVE FORMAT CAD FILE OF THIS DRAWING IS UNCONTROLLED. THE USER SHALL VERIFY TRACEABILITY OF THIS DRAWING TO THE LATEST CONTROLLED VERSION.



WARNING

THIS DRAWING HAS BEEN APPROVED BY A NEW YORK STATE PROFESSIONAL ENGINEER IN ACCORDANCE WITH NEW YORK EDUCATION LAW TITLE 8, ARTICLE 145, PARAGRAPH 7209. IT MUST NOT BE REVISED OR ALTERED IN ANY MANNER UNLESS AUTHORIZED BY A NYS LICENSED PROFESSIONAL ENGINEER.

10 5 0 10 20
SCALE: 1" = 10'-0"

 nationalgrid	BLACK & VEATCH NEW YORK, LLP		PROJECT #421275	ENGINEER AG DRAWN CHECKED CS DATE	03/17/2025	SSS 3/25/25
	PREPARED BY WILLIAM R. HOPKINS		NMPC SPIER FALLS HYDRO STATION 34	ORIGINAL ISSUE DATE	3/25/25	FINAL
	BV DES.		115KV-34.5KV STATION	FILE INDEX	2.0 - 513 - M27	67801
	DR. CK.		EXISTING CONDITIONS PLAN	DOWNING NUMBER	67801	001
REFERENCE DESCRIPTION	NO. DATE	DESCRIPTION OF REVISION	DR. CK. APP.	BV DES.	DR. CK.	APP.

A

C

D

W

E

G

FOR
H CONSTRUCTION ONLY

FOR

